


NOTES

- THIS DRAWING IS TO BE READ IN CONJUNCTION WITH ALL ENGINEERS & ARCHITECTS' DRAWINGS FIGURED DIMENSIONS ONLY (NOT SCALING) TO BE USED. WHERE A CONFLICT OF INFORMATION EXISTS OR IF IN ANY DOUBT - 'ASK'.
- CONSULTANTS TO BE INFORMED IMMEDIATELY OF ANY DISCREPANCIES BEFORE WORK PROCEEDS.
- THRUST BLOCKS ARE TO BE LOCATED AND INSTALLED AS PER UIUCE EIREANN DETAILS.
- REFER TO DRAWINGS FHI-00-XX-DR-BMCE-CE-10000 FOR GENERAL NOTES AND LEGENDS

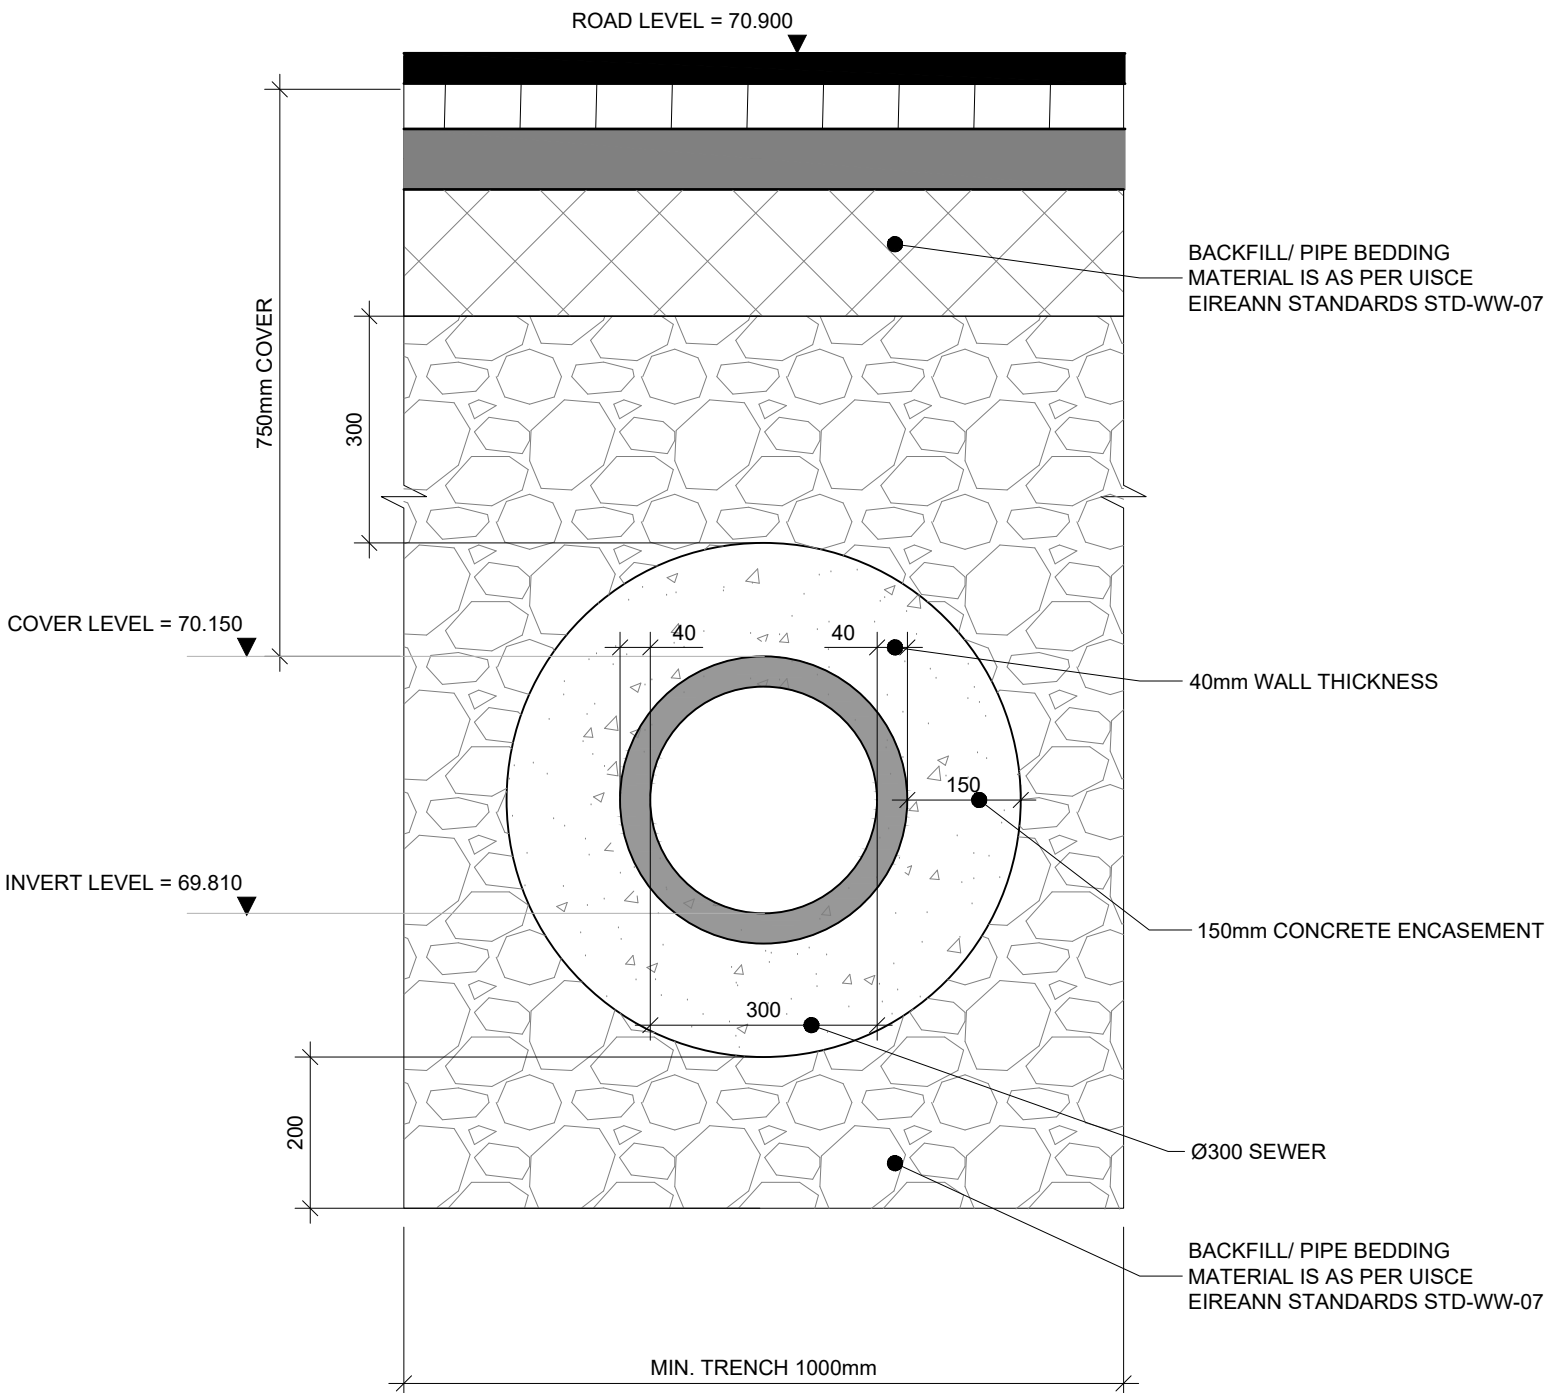

1 SECTION
11040
SCALE @ A1: 1:10
SCALE @ A3: 1:20

DRAINAGE LAYOUT

SCALE @ A1: 1:250
SCALE @ A3: 1:500

P01	23.10.25	ISSUED FOR PLANNING	E.C.
ISSUE	DATE	DESCRIPTION	BY
Project Engineer: Darragh O'Rourke		Project Director: Stephen O'Connor	
BM STAGE			
PLANNING			
<div><div><div>BM</div><div>BARRETT MAHONY</div></div><div><div>Dublin Office: Sandwith House, 52-54 Lower Sandwith Street, Dublin 2, Ireland. Tel: (01) 677 3200 Fax: (01) 677 3164</div><div>London Office: 5th Floor, Mill House, 8 Mill Street, London SE1 2BA, United Kingdom Tel: (0044) 20 3750 3530</div></div><div>Consulting Engineers, Civil - Structural - Project Management.E-mail: bmce@bmce.ie Web: www.bmce.ie</div></div>			
<div><div></div><div><div>The Institution of Structural Engineers</div><div>ACEI</div></div><div></div></div>			
CLIENT			
BLUEMONT DEVELOPMENTS LIMITED			
PROJECT TITLE			BM PROJECT No.
No.2 FIRHOUSE ROAD			24.309
MODEL	REFERENCE	SUITABILITY	REVISION
-	-	-	-
DRAWING TITLE			
PROPOSED DRAINAGE AND WATERMAIN LAYOUT			
DWG	DRAWING REFERENCE	STATUS	REVISION
	FHI-00-00-DR-BMCE-CE-11040	P8	P01